


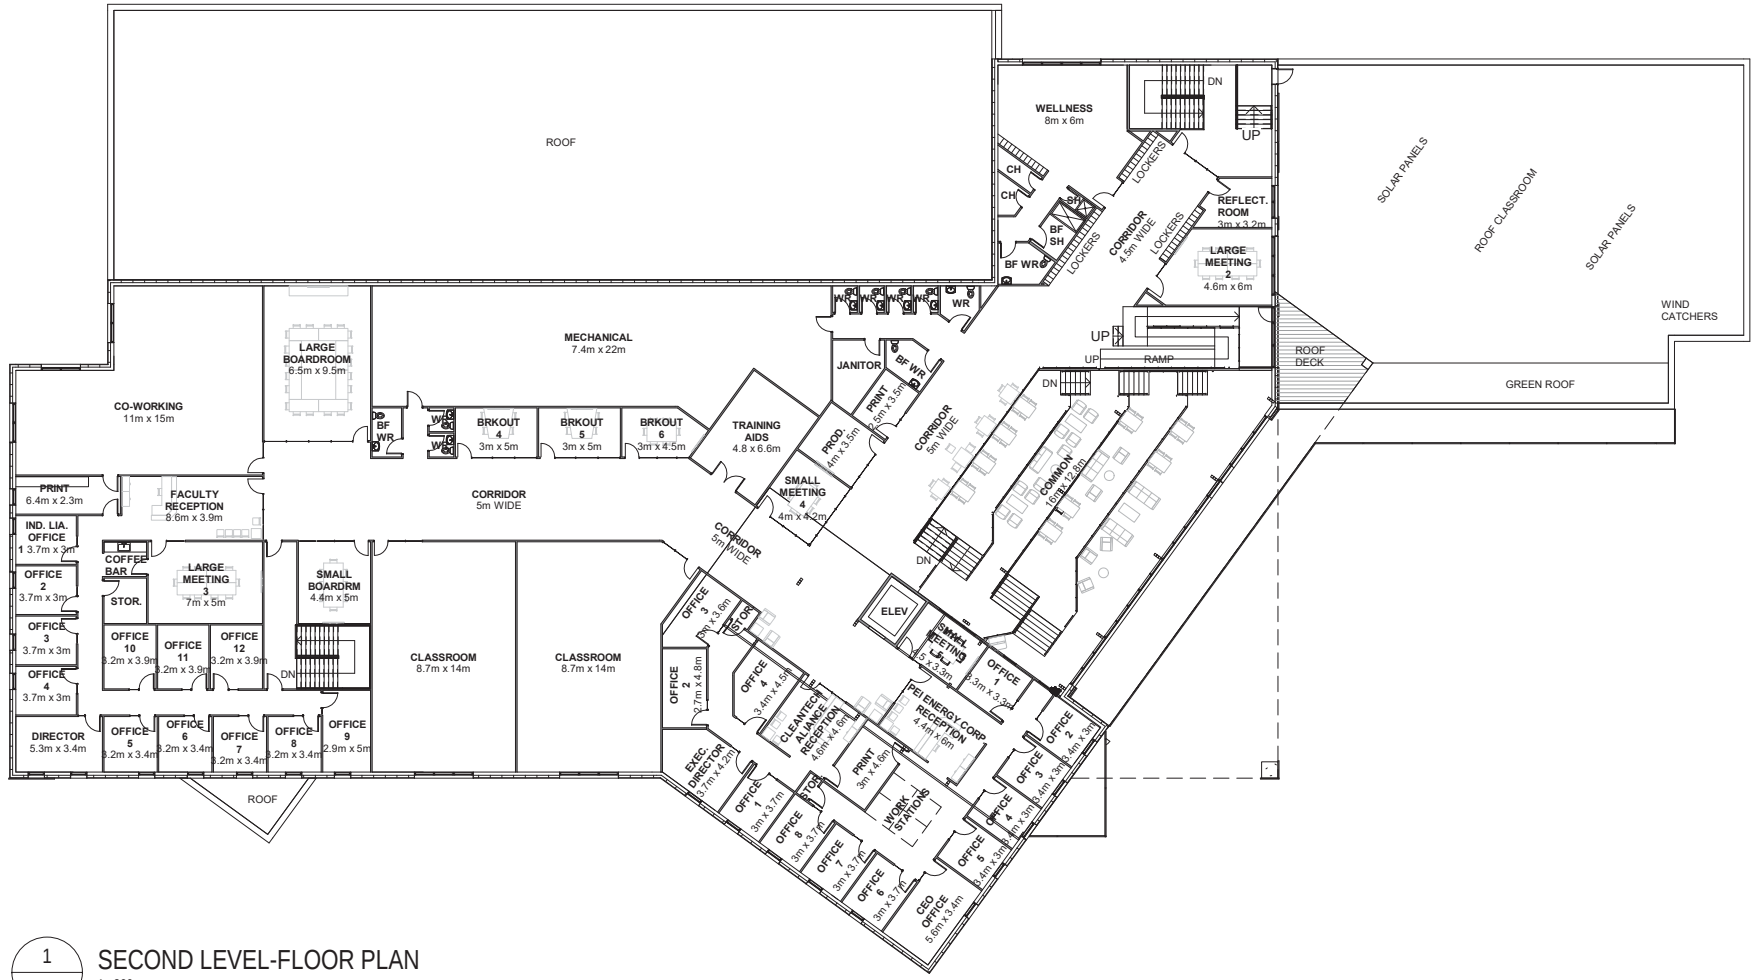

1 SECOND LEVEL-FLOOR PLAN
ASK003 1 : 300

COLES
Architecture + Engineering + Project Management

Suite 201, 85 Fitzroy Street
Charlottetown, P.E.I., Canada, C1A 1R6
Phone: (802) 368-2300
www.colesassociates.com

Client:
Finance PEI

Project Title:
Cleantech Learning and Innovation Centre, Georgetown PEI.

Sheet Title:
Floor Plan- Second Level

Date: 2023-08-07
Dn By: DC Chk By: WC

Project Number:
221101
Drawing Number:
ASK003

PRELIMINARY ONLY NOT FOR CONSTRUCTION